
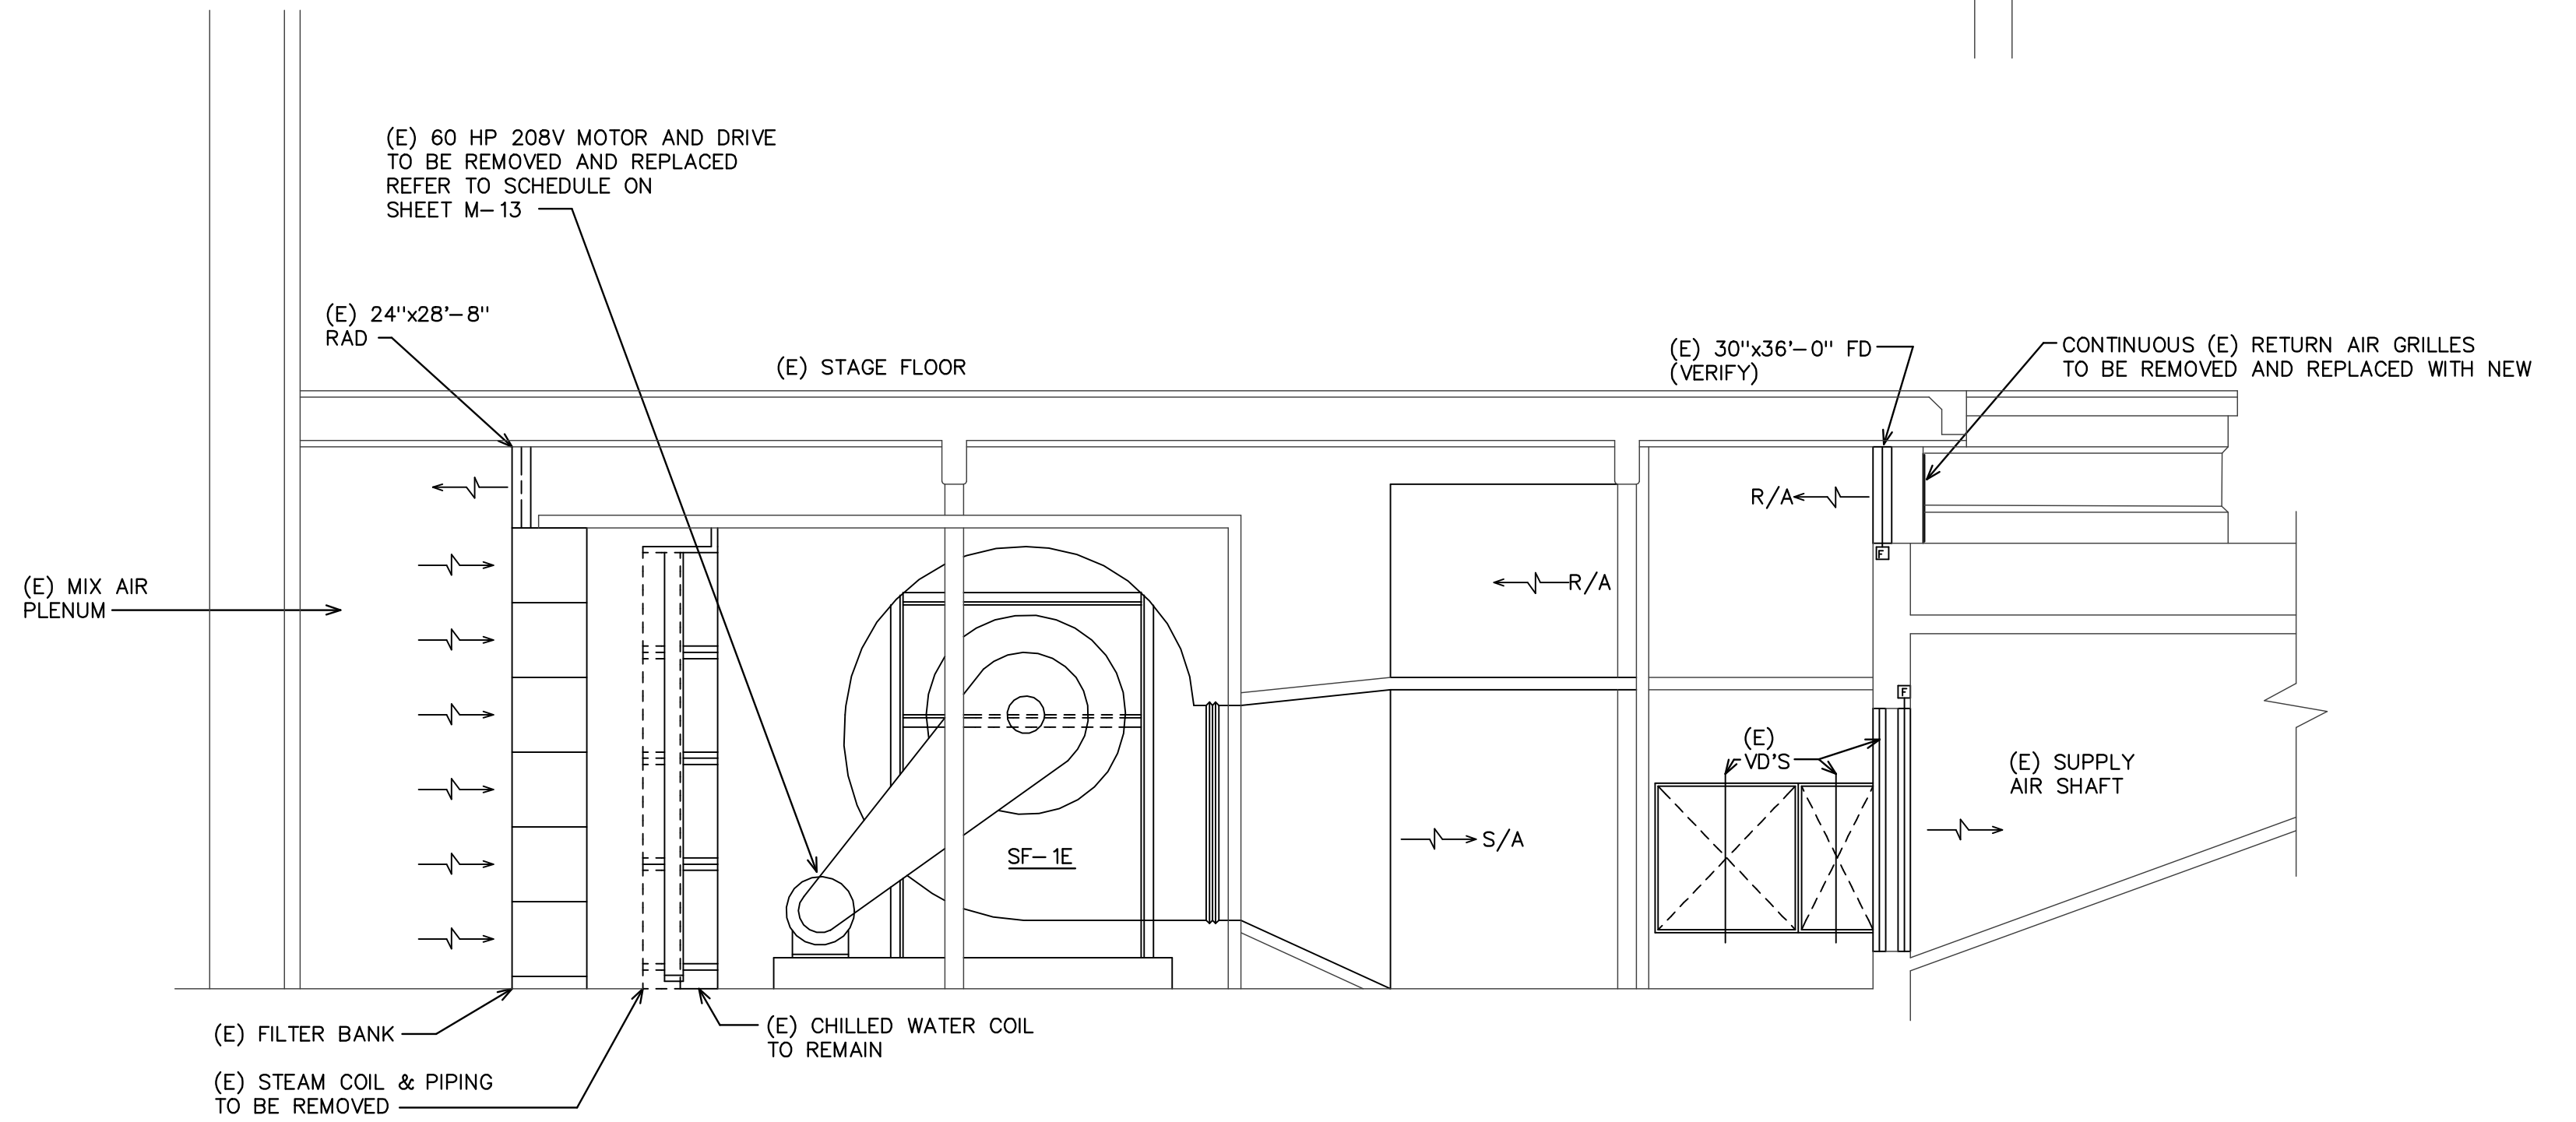


EXISTING/DEMOLITION
BASEMENT MECHANICAL FLOOR PLAN

SCALE: 1/4" = 1'-0"

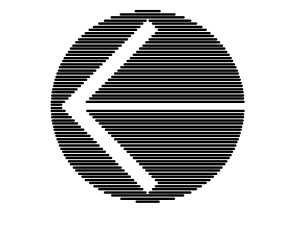

SECTION

SCALE: 1/4" = 1'-0"



CONFIDENTIALITY STATEMENT:
 The information, plans, designs and arrangements shown on this drawing are confidential and may not be reproduced in whole or in part without express written permission of Rolfe Engineering, Inc.



ROLFE ENGINEERING, INC.
 1036 W. ROBINHOOD DRIVE SUITE 201
 STOCKTON, CALIFORNIA 95207
 (209) 473-2859 FAX (209) 473-1312
 CALIF. P.E. #21002
 Copyright © 2009 Rolfe Engineering, Inc.

MEMORIAL CIVIC AUDITORIUM
EXISTING/DEMOLITION BASEMENT PLAN

PERMIT #09-2517

REV. NO.	DESCRIPTION	DATE	BY	APRVD.	CITY OF STOCKTON
	BID SET	8/27/09			
			SCALE:		APPROVED BY: DATE:
			DESIGNED BY: J.F.R.		SHEET NO.
			DRAWN BY: DAN		M-5
			CHECKED BY: J.F.R.		OF SHEETS
			RECORD DWG:		09-070