
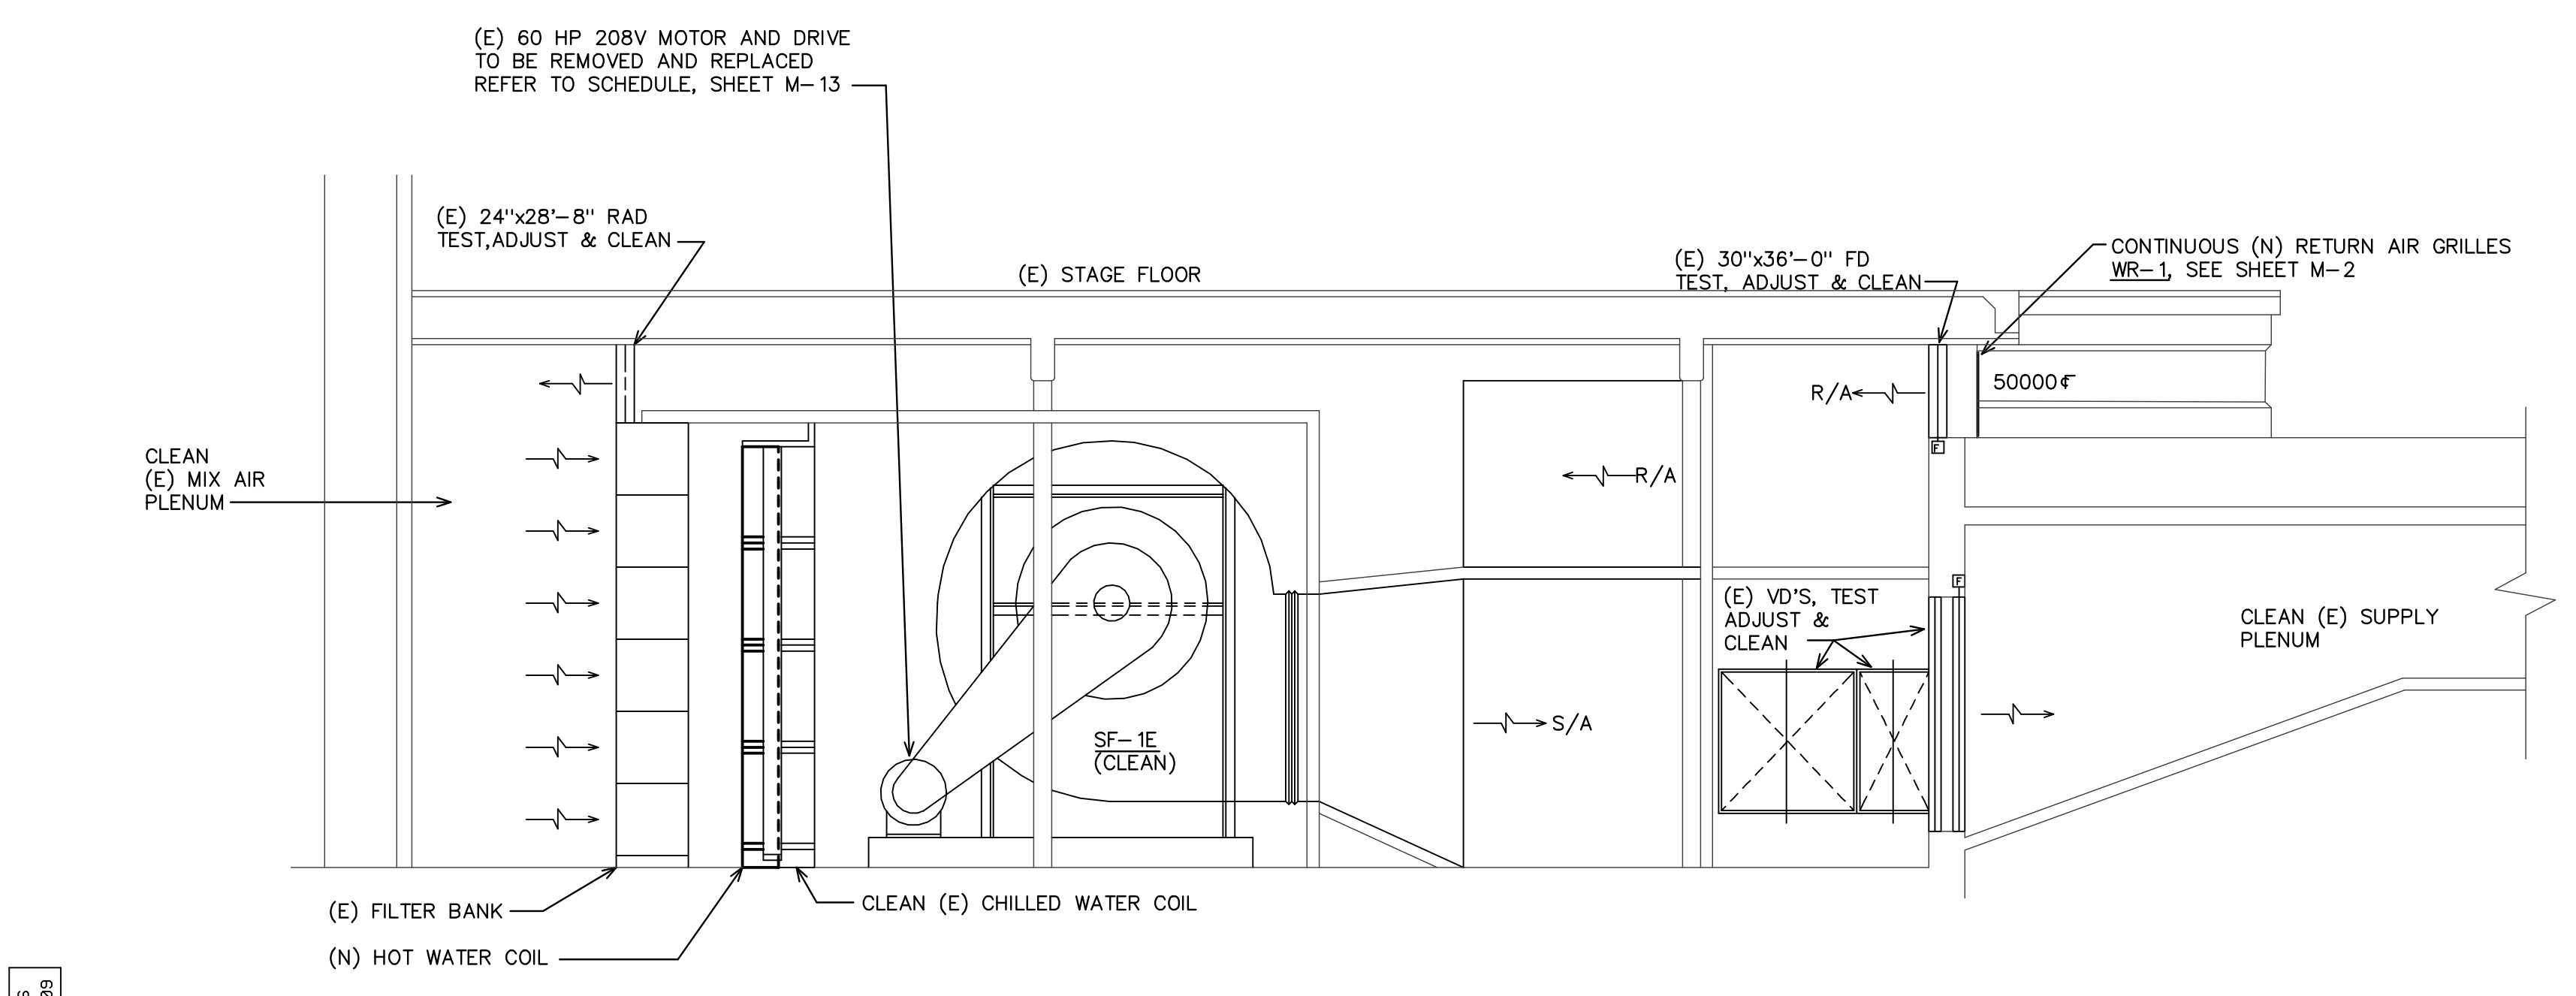



**REVISED/NEW**  
**BASEMENT MECHANICAL FLOOR PLAN**

SCALE: 1/4" = 1'-0"

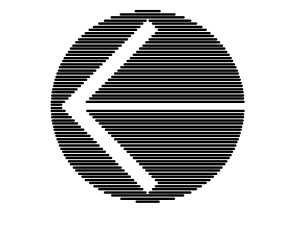


**SECTION**

SCALE: 1/4" = 1'-0"

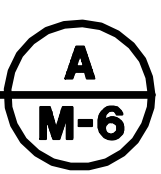

**CONFIDENTIALITY STATEMENT:**  
 The information, plans, designs and arrangements shown on this drawing are confidential and may not be reproduced in whole or in part without express written permission of Rolfe Engineering, Inc.

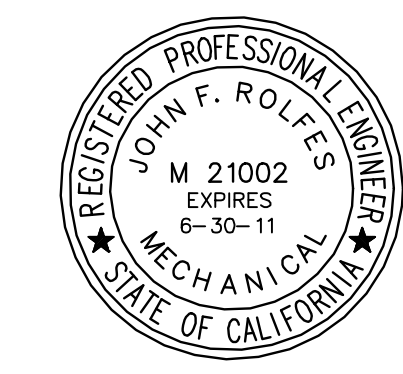

**ROLFE ENGINEERING, INC.**  
 1036 W. ROBINHOOD DRIVE SUITE 201  
 STOCKTON, CALIFORNIA 95207  
 (209) 473-2859 FAX (209) 473-1312  
 CALIF. P.E. #21002  
 Copyright © 2009 Rolfe Engineering, Inc.

**MEMORIAL CIVIC AUDITORIUM**  
**REVISED/NEW BASEMENT PLAN**

PERMIT #09-2517

REV. NO.	DESCRIPTION	DATE	BY	APRVD.	CITY OF STOCKTON
BID SET		8/27/09		SCALE:	APPROVED BY: DATE:
				DESIGNED BY: J.F.R.	SHEET NO.
				DRAWN BY: DAN	<b>M-6</b>
				CHECKED BY: J.F.R.	OF SHEETS
				RECORD DWG:	09-070